


# FCU CONTROLS (MODULATING TYPE)

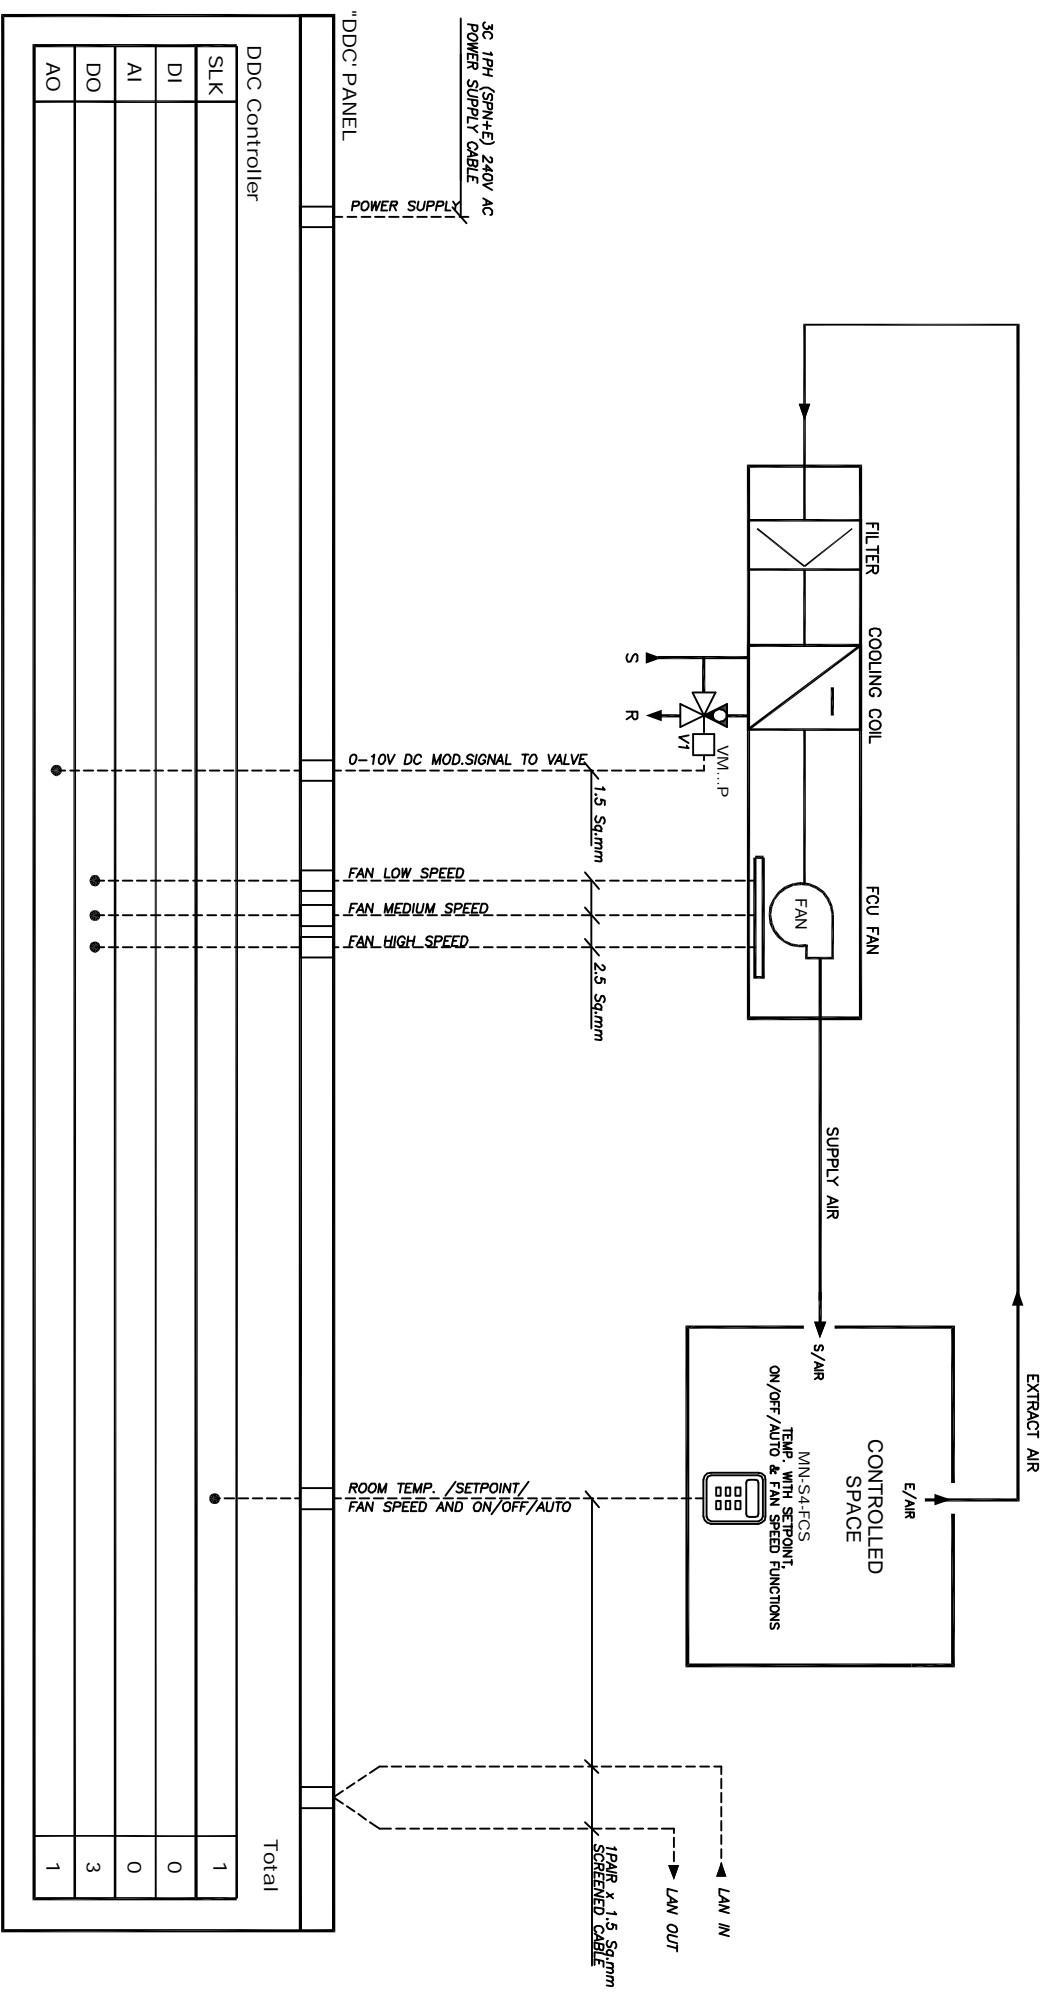

"DDC" PANEL	
POWER SUPPLY	
3C 1PH (SPN+E) 240V AC POWER SUPPLY CABLE	
DDC Controller	
SLK	1
DI	0
AI	0
DO	3
AO	1
Total	

Rev	1	2	3	4	5	6	7	8	9	10	11	12	
Description		Date		Appd.		Contractor:		Project:		Title:			
<b>FCU CONTROLS SCHEMATIC DIAGRAM (MODULATING TYPE)</b>								Drawn by Checked by Approved by Date		<b>AL TAQA</b> AL TAQA EQUIPMENTS L.L.C P.O BOX - 70150, ABU DHABI UNITED ARAB EMIRATES C - 644 2993 * FAX - 644 3802 email - altaqa@emirates.net.ae		Drawing No. <b>ATE-STD-FCU-03</b>	Rev. Sheet 1 of 1